


FIRST FLOOR PLAN

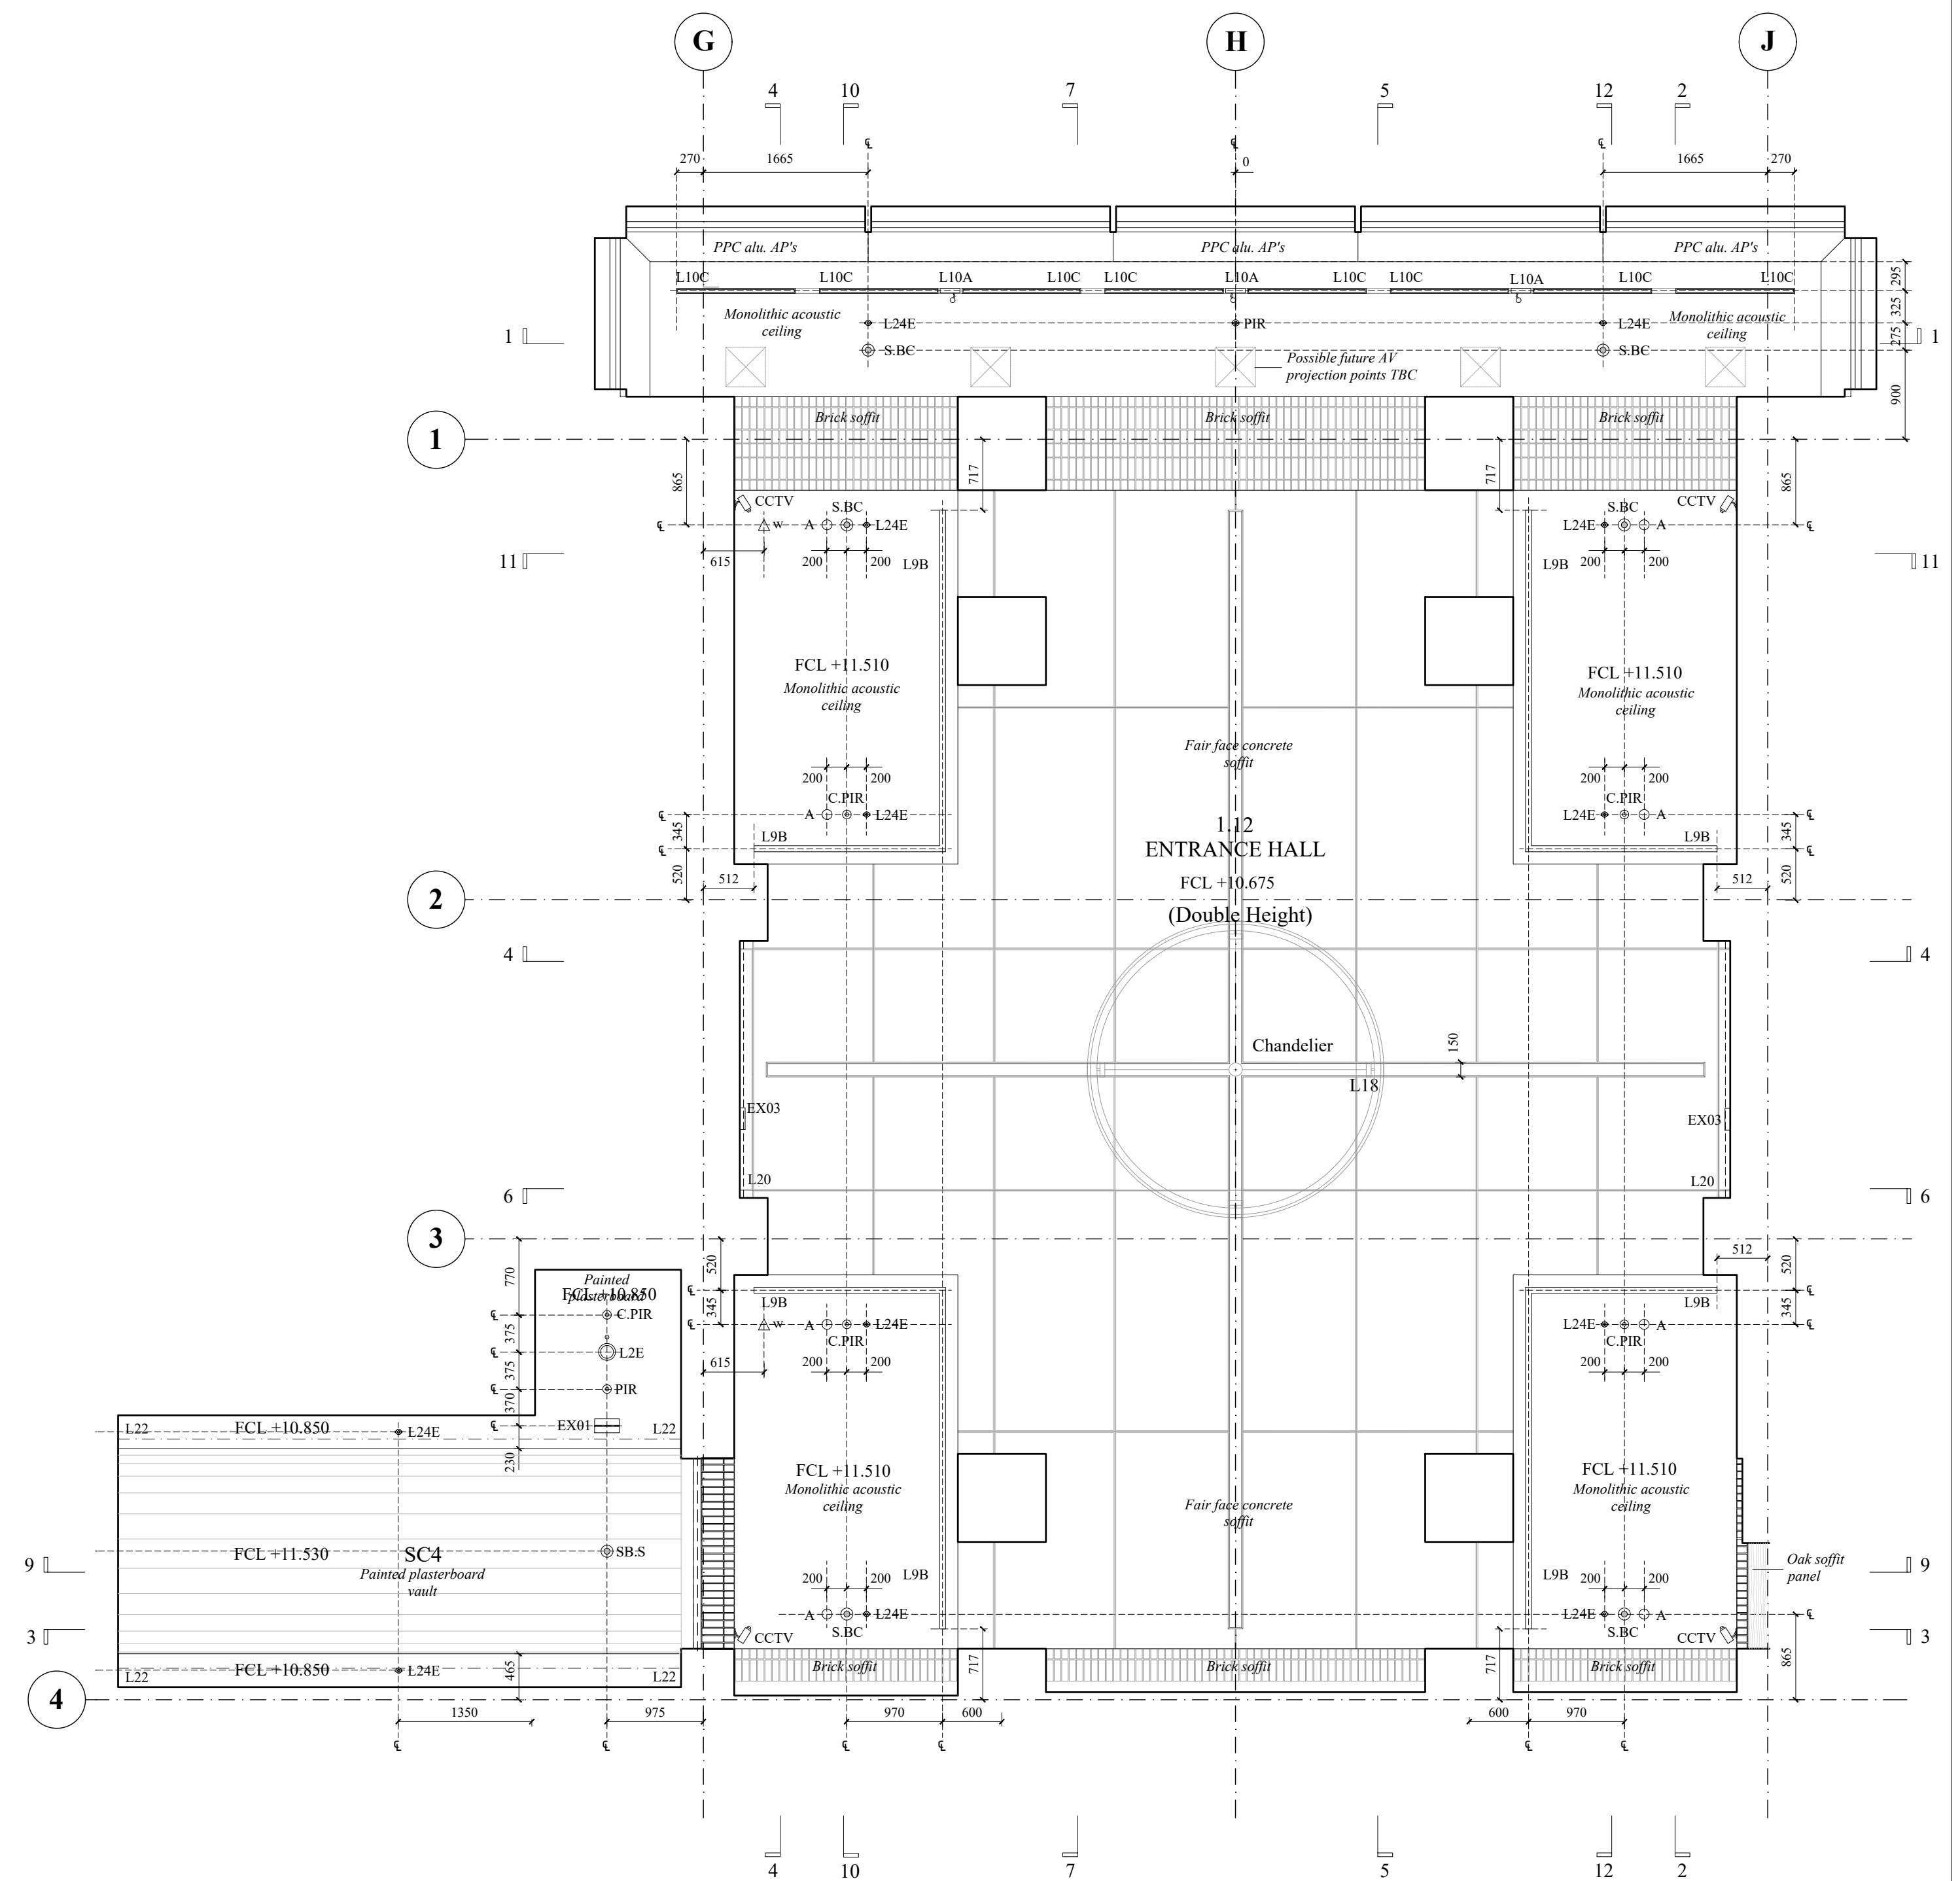

REFLECTED CEILING PLAN

REVISIONS:

Rev A	28.07.17	Co-ordinated
Rev B	04.08.17	Feature light fitting revision. L23 Track lighting added.
Rev C	10.08.17	Emergency exit fittings added.
Rev D	15.02.19	Construction Coordination updates.
Rev E	19.07.19	Construction WiFi access point shown in SW quadrant.
Rev F	30.07.19	Construction WiFi access point shown in NW quadrant.
Rev G	12.12.19	Construction Temporary partition shown between 1.07 & 1.12.
Rev H	12.02.20	Construction Access Panels omitted. Floor box setting-out shown.
Rev H	30.06.20	Final Issue

For standard setting out of sockets, switches, access controls and alarms, please refer to (S) 350 unless otherwise stated.

FLOOR PLAN

- Double switched socket
- Double unswitched socket
- Single switched socket
- Single unswitched socket
- Us-switched line connection
- Fire alarm interface unit
- Floor Box - Entrance
- Manual light switch
- Blind control switch
- BMS environmental logger
- Panic Alarm
- Manual Call Point

CONDUIT

- Floor Box - Typical
- TELECOMS OUTLET
- WiFi ACCESS POINT
- SUSPENDED SOCKET
- INTERNAL LIGHT
- EXTERNAL LIGHT
- EXTERNAL LIGHT
- MAIN FIRE ALARM PANEL
- MANUAL CALL POINT (BREAKGLASS)
- LIGHT AND BUZZER UNIT
- HEAT DETECTOR
- HEAT DETECTOR WITH BEACON BASE

LIGHTING

- BMS
- Data
- Lighting
- Power
- Security
- Fire alarm
- Vesda

ELEVATION

- HEAT DETECTOR WITH SOUNDER & BEACON BASE
- ASPIRATING SMOKE DETECTION POINT
- POINT SMOKE DETECTOR
- SMOKE DETECTOR WITH BEACON BASE
- SMOKE DETECTOR WITH SOUNDER & BEACON BASE
- SOUNDER BEACON
- FLASHING BEACON (VISUAL ALARM DEVICE - VAD)
- ASPIRATING SMOKE DETECTOR UNIT
- VOICE ALARM/PA SURFACE MOUNTED LOUDSPEAKER
- DOME CAMERA
- EXTERNAL DOME CAMERA
- EXTERNAL CAMERA
- INDUCTION LOOP CABLE
- EXTERNAL CCTV CAMERA
- GRADE 3 DUAL TECH PIR

ACCESS CONTROL

- UNSWITCHED FUSED CONNECTION (MOTORISED DOOR)
- UNSWITCHED FUSED CONNECTION (SOLENOID VALVE)
- ACCESS CONTROL CARD READER
- GRADE 3 RISCO LUNAR DT AM PIR
- GREEN BREAK GLASS UNIT
- PUSH TO EXIT BUTTON
- TWO BUTTON PUSH PANIC BUTTON
- TWO BUTTON PANIC ALARM
- DOOR WINDOW CONTACT
- SECURITY KEY PAD
- INDUCTION LOOP CABLE
- ASSISTANCE ALARM PULL CORD
- ASSISTANT ALARM OVERDOOR BUZZER AND INDICATOR UNIT

VENTILATION

- REASSURANCE LAMP
- DISABLED REFUGE INTERCOM
- FLOOR GROMMET
- LINEAR SUPPLY AIR GRILLE
- LINEAR FIXED BLADE EXHAUST AIR GRILLE
- SQUARE EXTRACT AIR GRILLE
- FIXED BLADES EXHAUST GRILLE
- LINEAR EXTRACT AIR GRILLE

NOTES

- Provision per desk seating position 2no. twin switched socket outlets 4no. RJ45 data ports.
- Provision per floor box 2no. twin switched socket outlets 4no. RJ45 data ports.
- Provision per project position 1no. twin switched socket outlets 2no. RJ45 data ports.

LAMBETH PALACE LIBRARY

ROOM LAYOUT
1.12 ENTRANCE HALL

SCALE
1:50 @ A1

DATE:
14.02.2017

DRAWING NO:
318H

WRIGHT & WRIGHT ARCHITECTS

89/91 Bayham Street
London NW1 0AG
TEL 020 7428 9393
FAX 020 7428 9394
www.wrightandwright.co.uk
www.wrightandwright.co.uk